


Project:	The Best Little Whorehouse in Texas
	Tempo Musical Productions: Fringe '02
Drawing:	Portobello Town Hall: Lighting Plan
Drawn:	Mike Hume
Version:	1.0 (20 August 2002)
Scale:	Original: 1in = 4ft This print: =

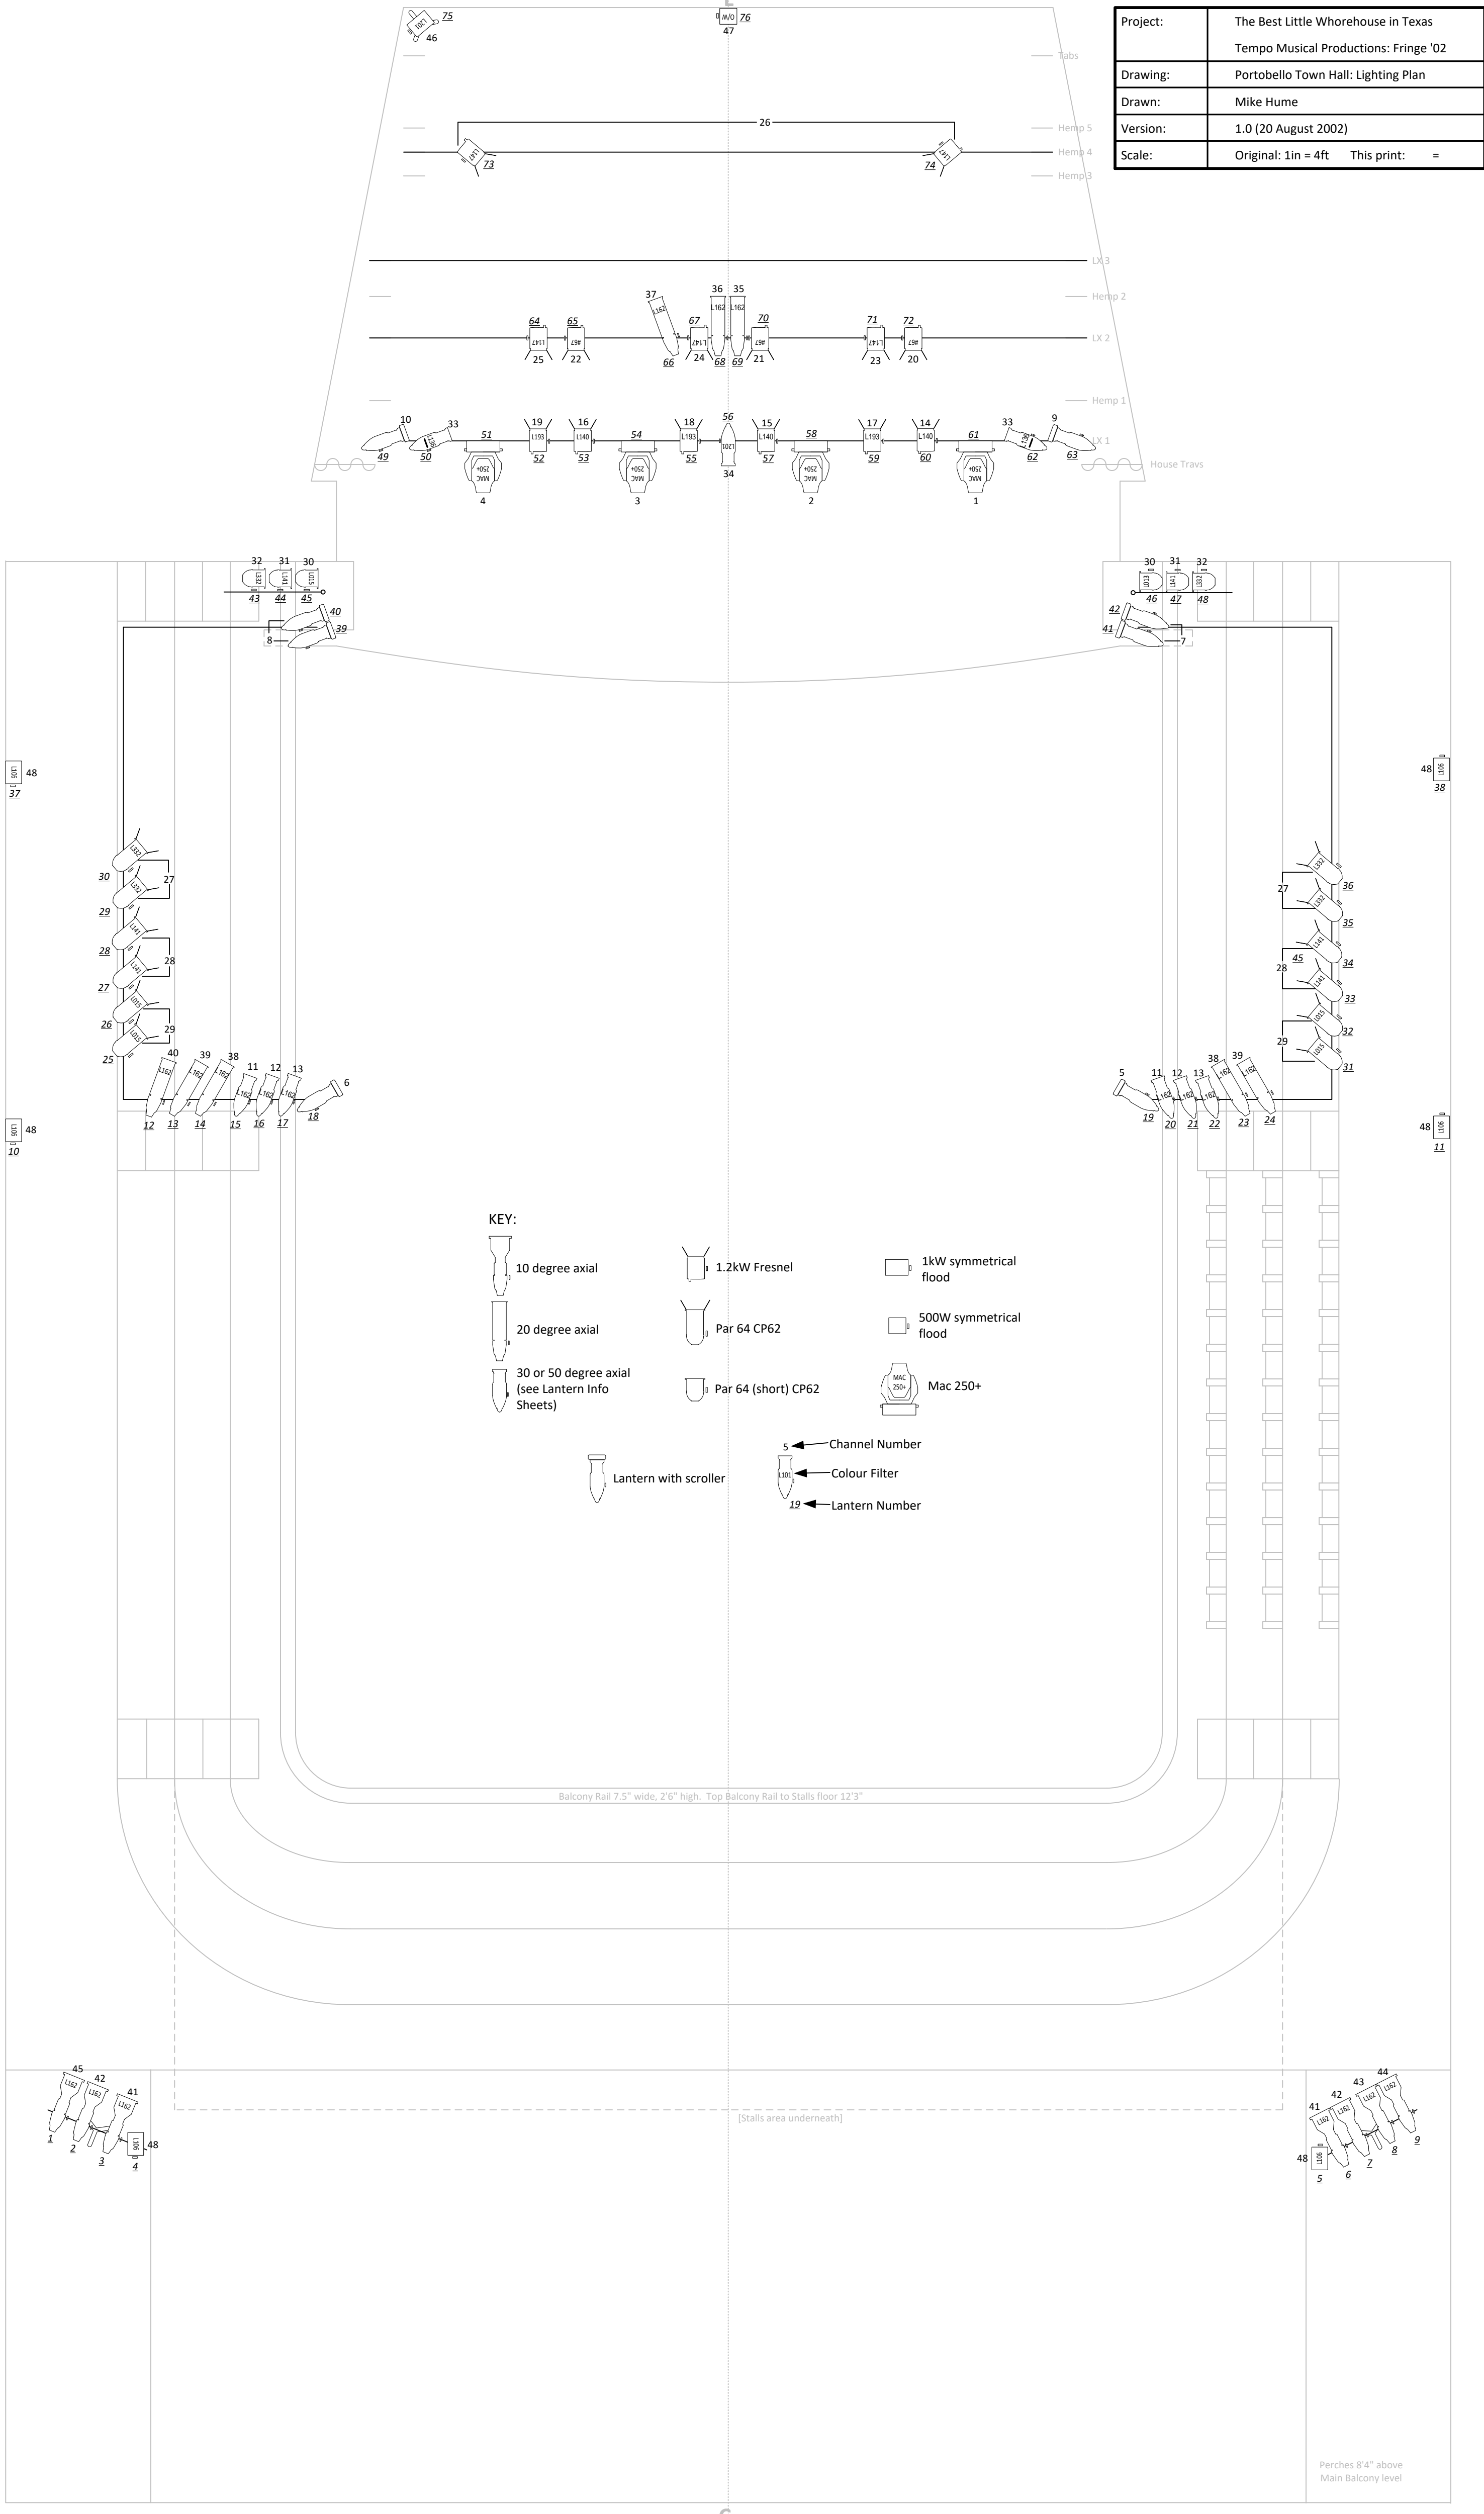

- KEY:**
- 10 degree axial
 - 20 degree axial
 - 30 or 50 degree axial (see Lantern Info Sheets)
 - Lantern with scroller
 - 1.2kW Fresnel
 - Par 64 CP62
 - Par 64 (short) CP62
 - 1kW symmetrical flood
 - 500W symmetrical flood
 - Mac 250+
- Channel Number
 Colour Filter
 Lantern Number

Balcony Rail 7.5" wide, 2'6" high. Top Balcony Rail to Stalls floor 12'3"

[Stalls area underneath]

Perches 8'4" above Main Balcony level